

NB: GCC ROADS DESIGN PROPOSALS WILL BE SUBJECT TO GCC PARKS & GCC ROADS AUTHORITY APPROVAL

NB KERBS TO THE INTO EXISTING AT LOCATIONS SHOWN


NB KERBS TO THE INTO EXISTING AT LOCATIONS SHOWN

NB PROPOSED WORKS ARE TO THE INTO EXISTING PUBLIC ROAD/FOOTWAY AT THESE LOCATIONS


NB REINSTATEMENT DRAINING MEASURE EXISTING LOCATION TO BE REPLACED BY RAIN GARDENS

NB KERBS TO THE INTO EXISTING AT LOCATIONS SHOWN


NB PROPOSED WORKS ARE TO THE INTO EXISTING PUBLIC ROAD/FOOTWAY AT THESE LOCATIONS

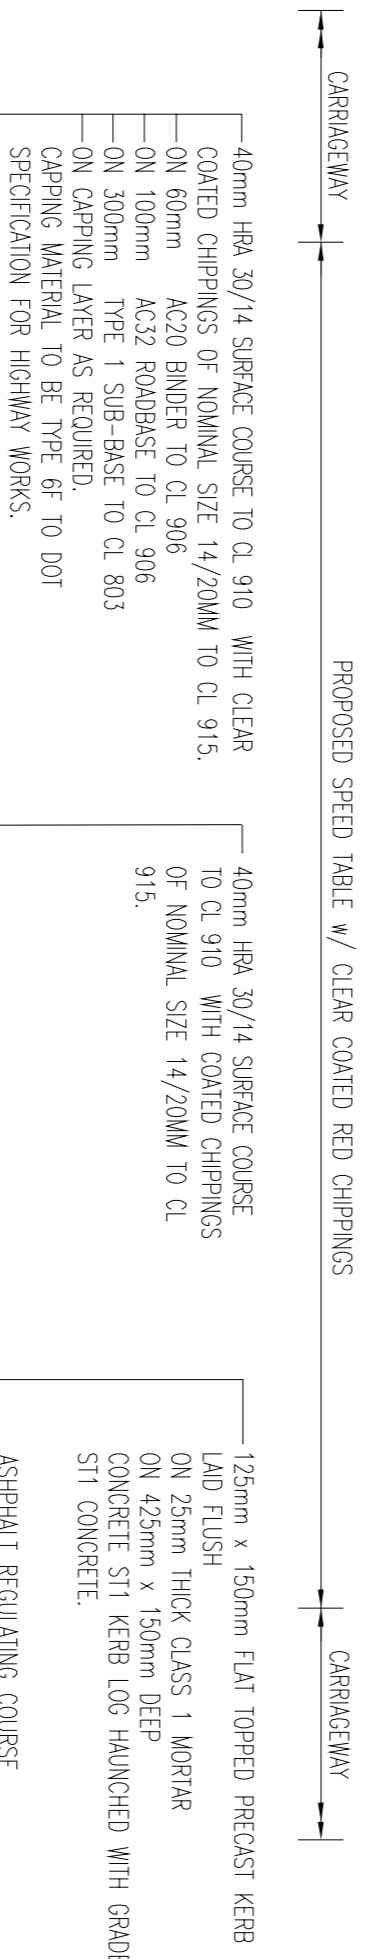


TYPICAL SECTION THROUGH SPEED TABLE (REFER TO DRAWING 9501 FOR RAIN GARDEN DETAIL) (NTS)

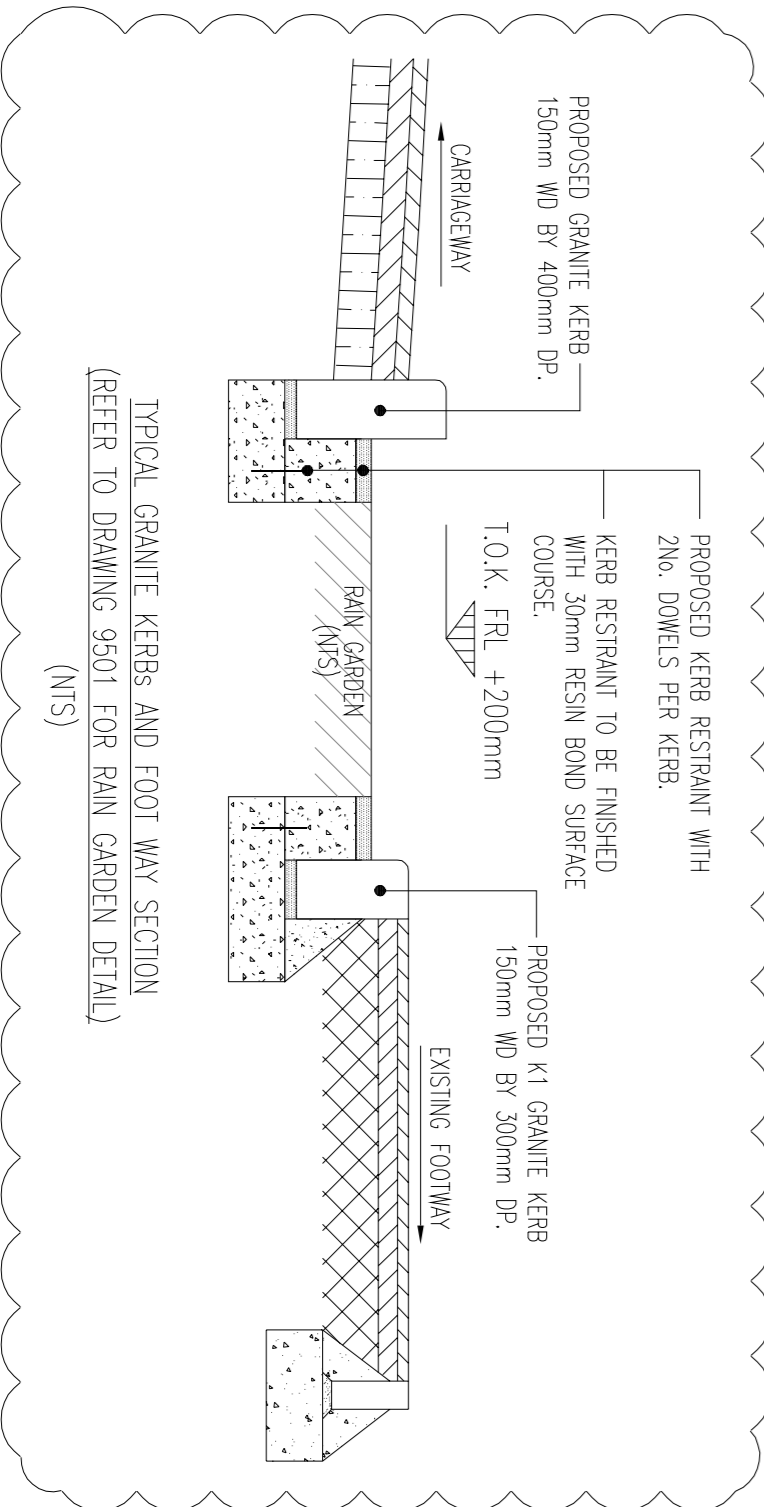


TYPICAL GRANITE KERBS AND FOOT WAY SECTION (REFER TO DRAWING 9501 FOR RAIN GARDEN DETAIL) (NTS)

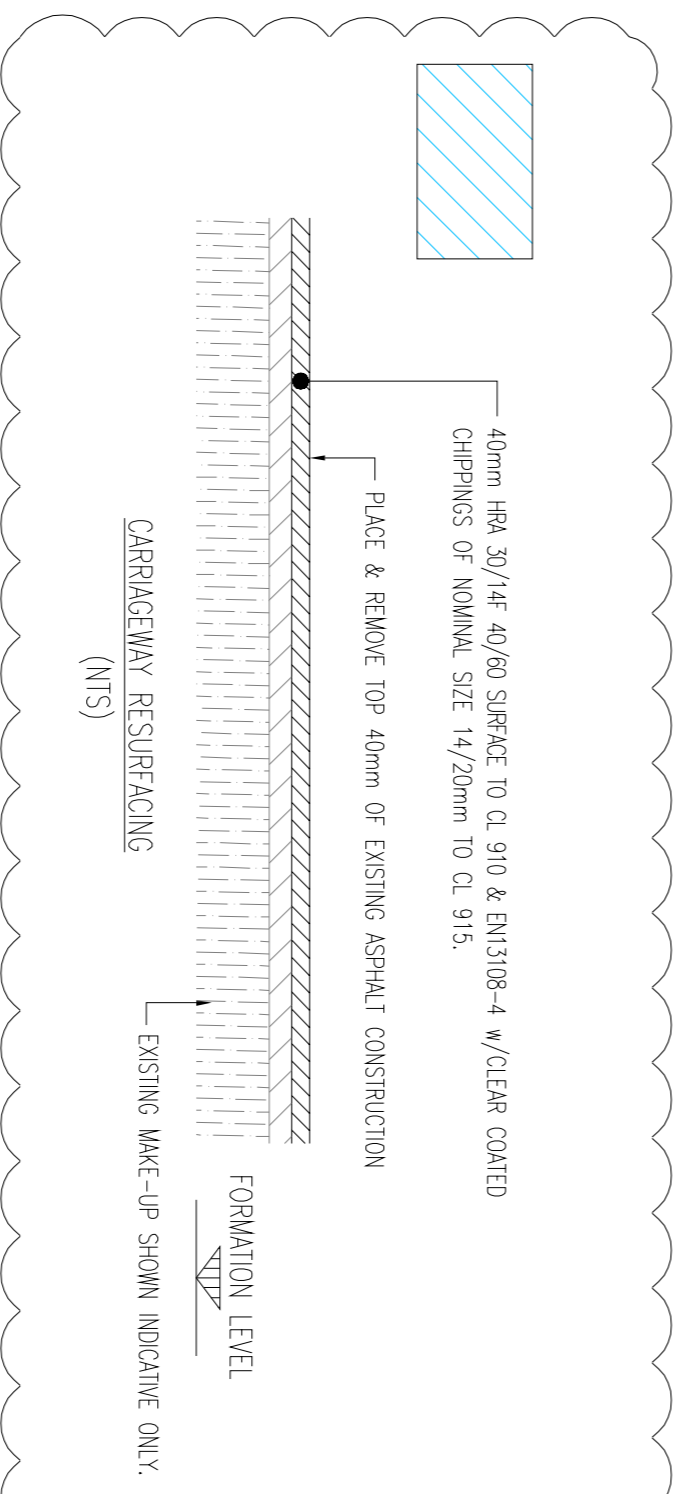


PROPOSED FOOTWAY/FOOTPATH MAKE UP (PUBLIC) (NTS)

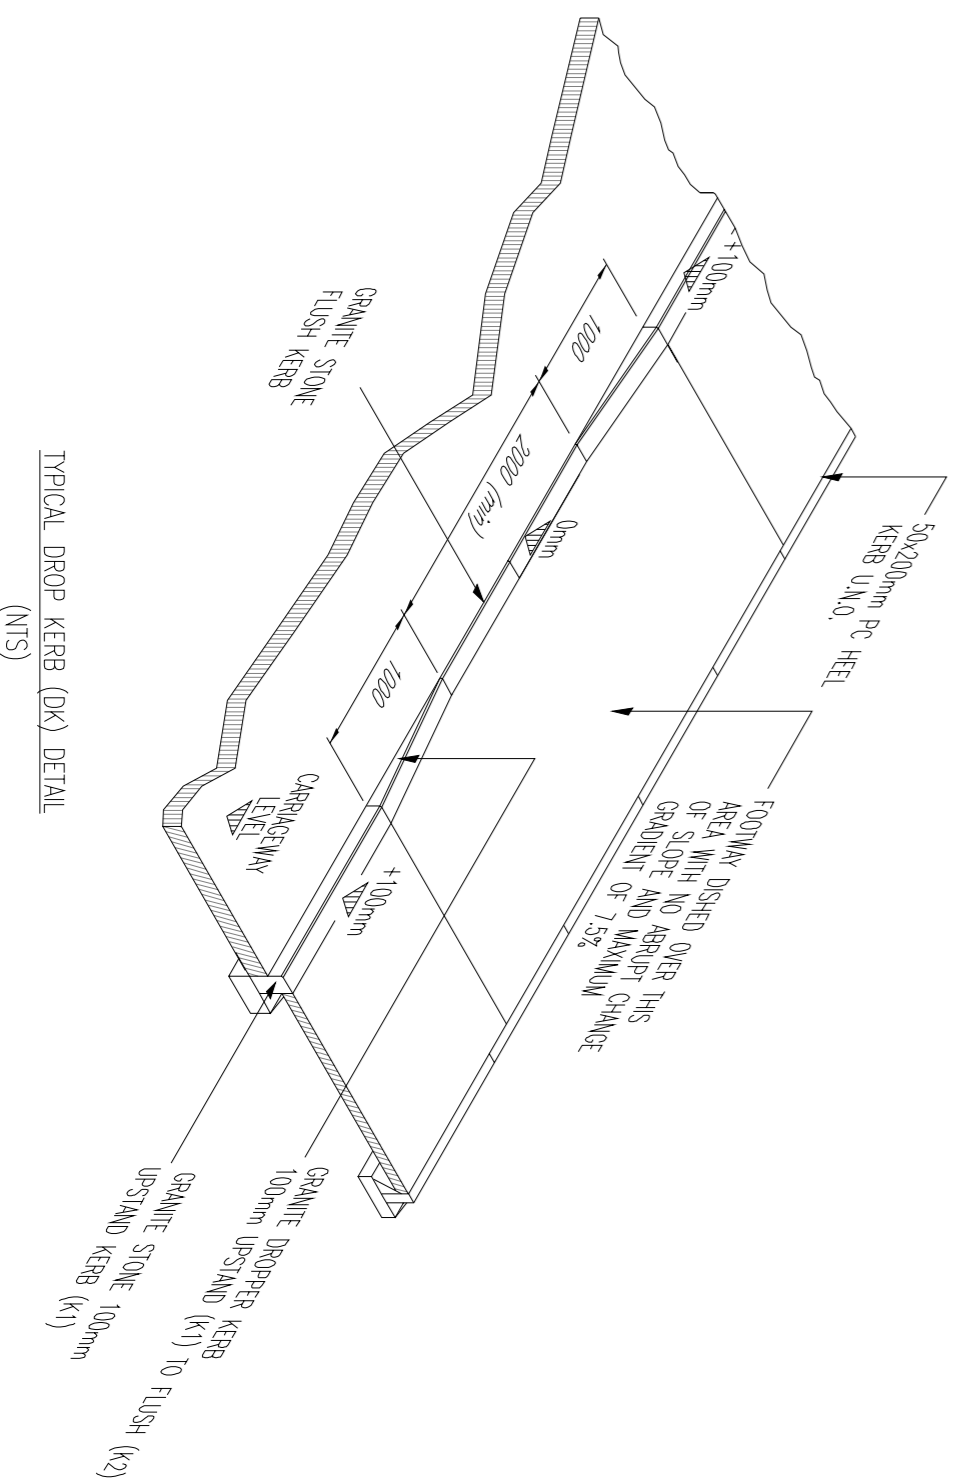

TYPICAL DROP KERB (K1) DETAIL (NTS)

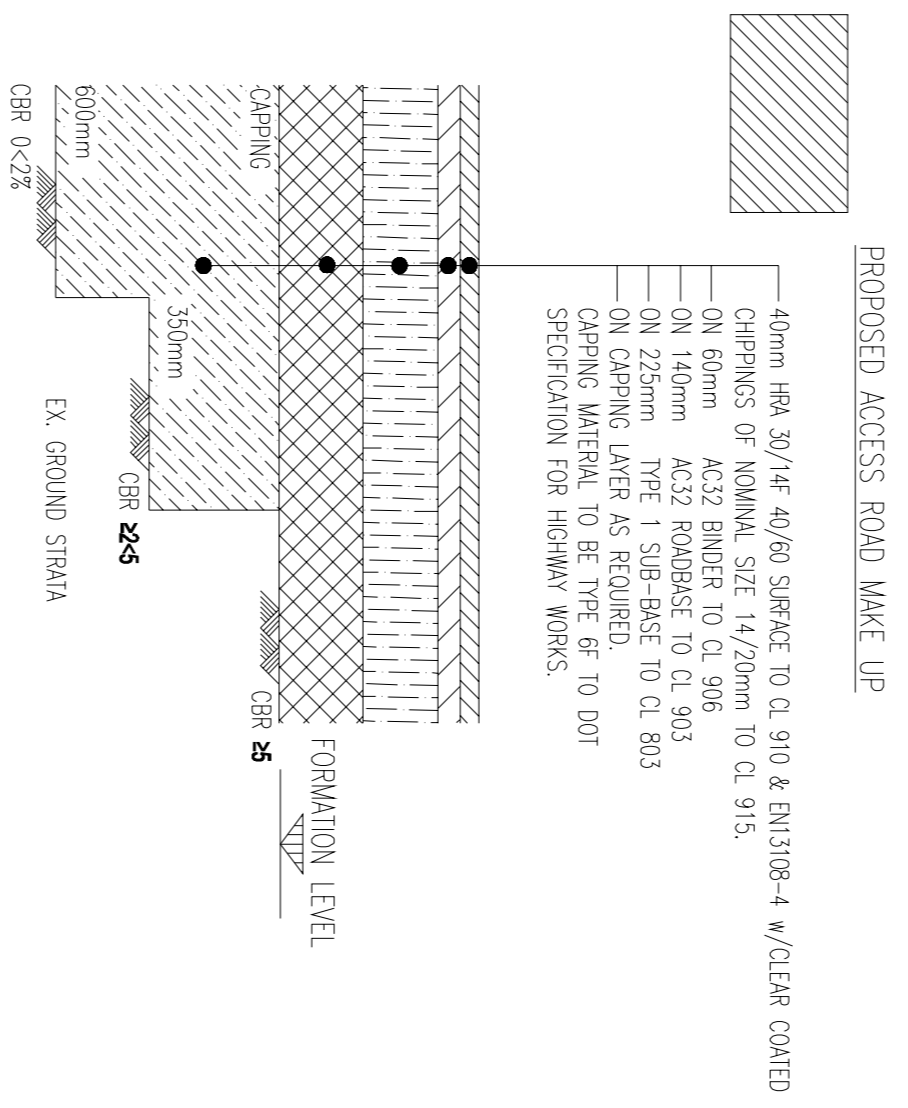


PROPOSED ACCESS ROAD MAKE UP

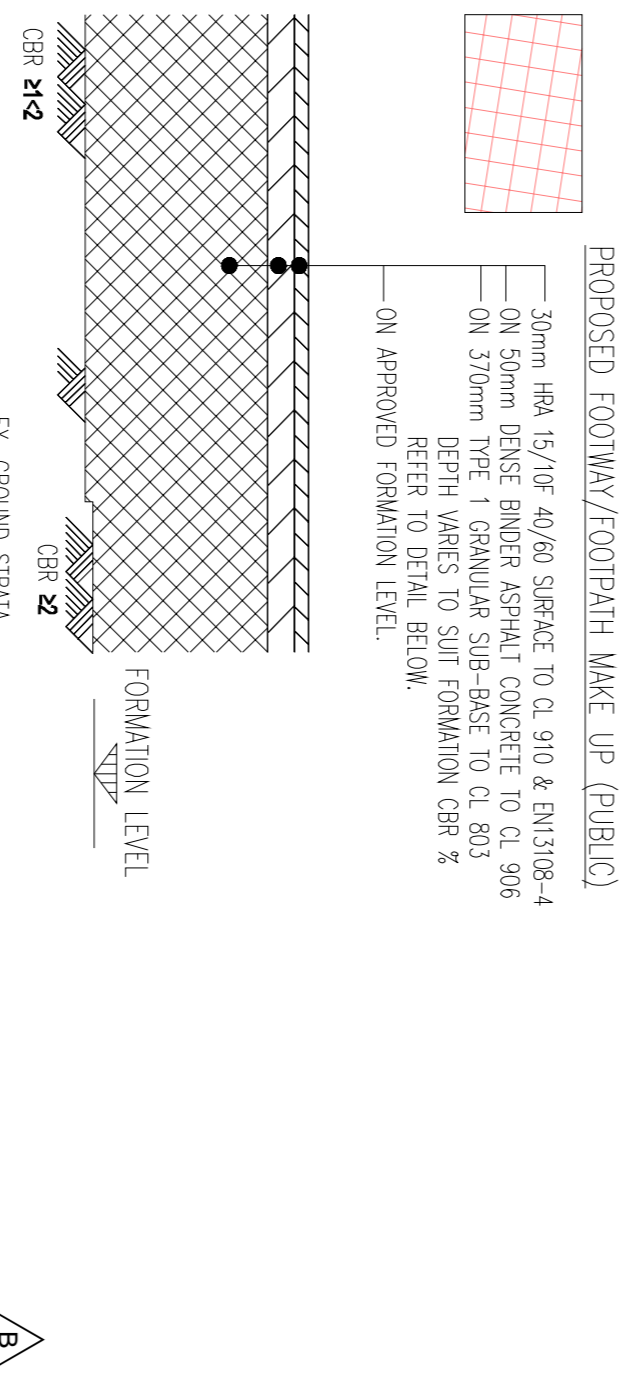

PROPOSED ROAD CONSTRUCTION

EXISTING ROAD CONSTRUCTION

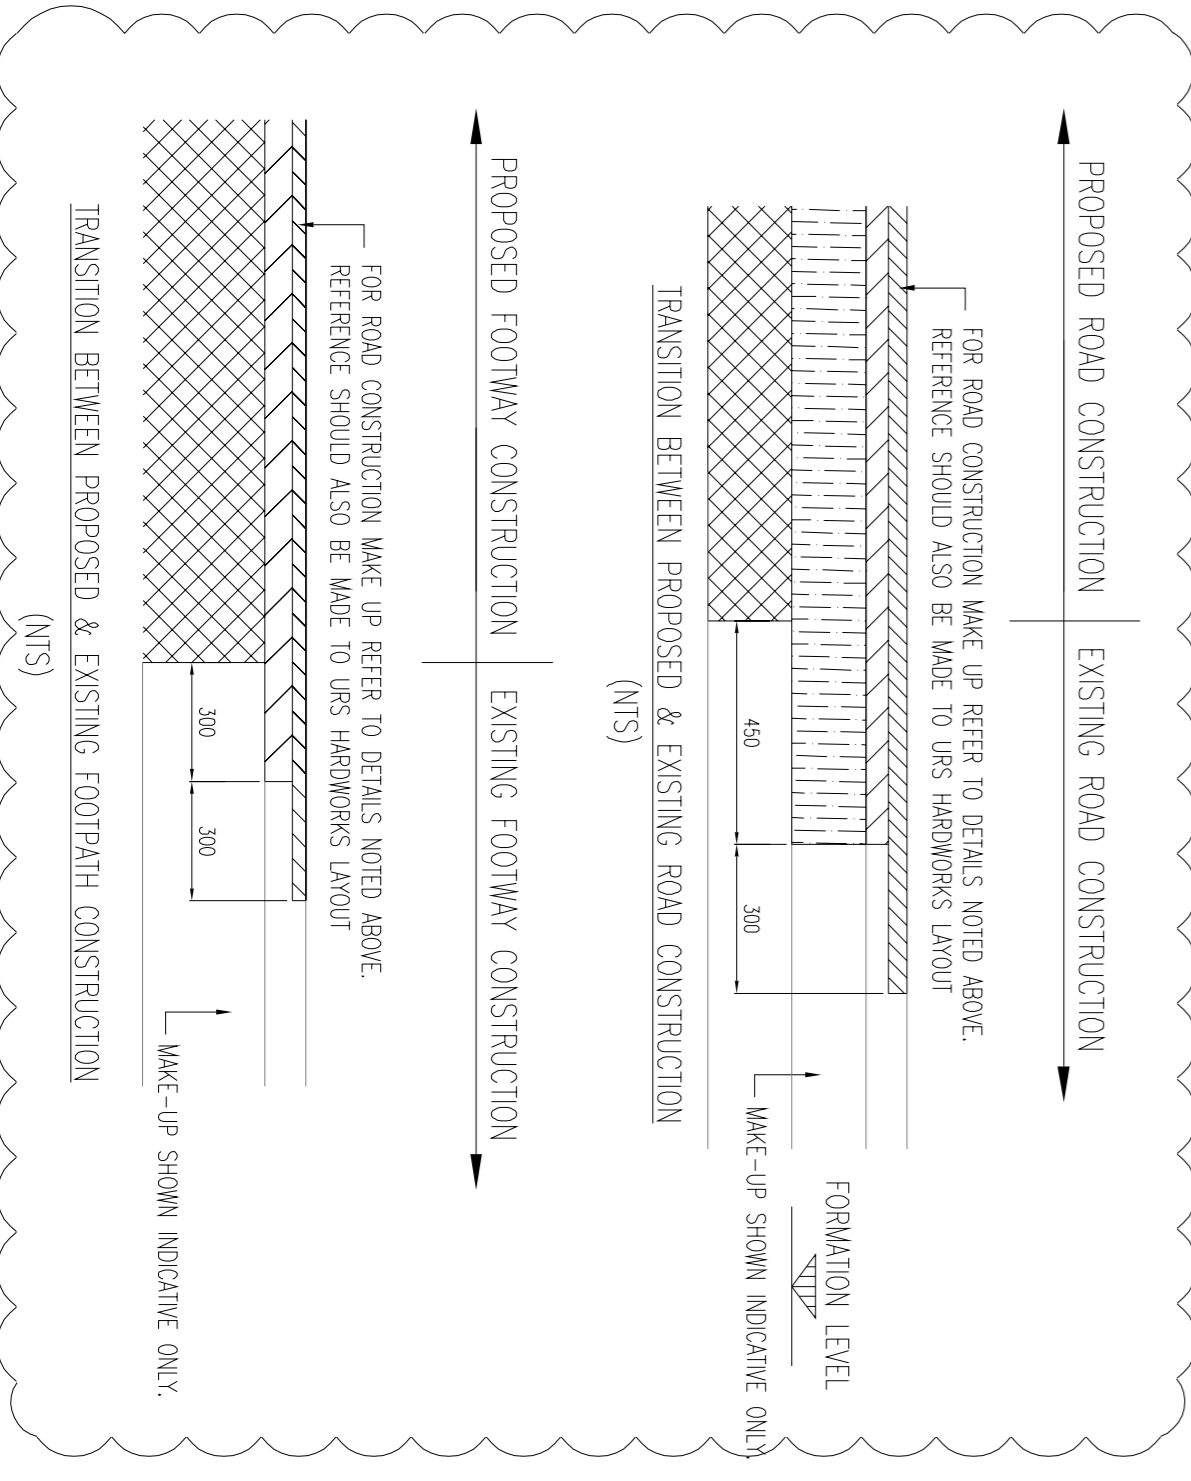

PROPOSED FOOTWAY CONSTRUCTION

EXISTING FOOTWAY CONSTRUCTION

TRANSITION BETWEEN PROPOSED & EXISTING FOOTPATH CONSTRUCTION (NTS)

TRANSITION BETWEEN PROPOSED & EXISTING FOOTWAY CONSTRUCTION (NTS)

# AECOM

PROJECT  
**SOUTH EAST OF GLASGOW ~ SWMP**


CLIENT  
**GLASGOW CITY COUNCIL**

CONSULTANT  
**AECOM**  
 7th Floor, Aurora  
 120 Bothwell Street  
 GLASGOW, G2 7JS  
 +44 (0) 141 248 0300 tel  
 +44 (0) 141 248 0303 fax  
 www.aecom.com

**NOTES**

1. THIS DRAWING SHOULD BE READ IN CONJUNCTION WITH ALL OTHER RELEVANT DRAWINGS AND SPECIFICATIONS BY THE ENGINEER.
2. BASE ORNANCE SURVEY DATA HAS BEEN SUPPLIED BY GLASGOW CITY COUNCIL UNDER CONTRACTOR LICENSE BETWEEN GLASGOW CITY COUNCIL AND AECOM LIMITED DATED 31 MARCH 2017. ALL DATA PROVIDED TO AECOM LIMITED BY GLASGOW CITY COUNCIL IS FOR USE ON THIS CONTRACT ONLY.

**KERBING LEGEND**

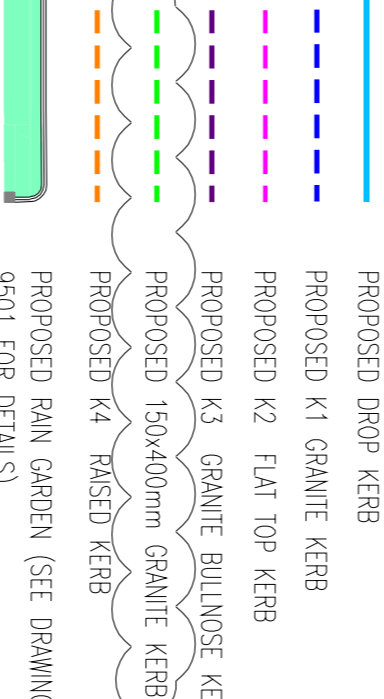

NOTE: REINSTATEMENT TO KERBING AND DRAINAGE REQUIRED BUT NOT SHOWN ON PLAN. REFER TO KERBING AND DRAINAGE LAYOUT FOR DETAILS.


**REFERENCE DRAWINGS**

- 60541410/5953 - EXISTING SERVICES
- 60541410/5953 - PROPOSED DRAINAGE
- 60541410/5953 - SITE CLEARANCE
- 60541410/5953 - LINES & SERVICE
- 60541410/9501 - PROPOSED RAIN GARDEN DETAILS

**ISSUE/REVISION**

NO	DATE	DESCRIPTION
B	23.08.18	NEW KERBS ADDED ROAD AND PARALLEL TRANSITION DETAIL ADDED.
A	19.02.18	UPDATED TO TAKEOVER

**KEY PLAN**

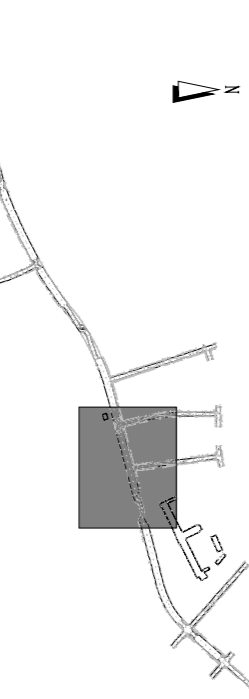

PROJECT NUMBER  
 60541410

SHEET TITLE  
**CROYPARK AVENUE PROPOSED KERBING & HARDWORKS SHEET 4 OF 5 1:250 @ A1**

SHEET NUMBER  
 60541410 - SH1 - 00 - 0000 - C - 5073a

**FOR INFORMATION**